


PRELIMINARY NOT FOR CONSTRUCTION

Replace plumbing fixtures
 Replace toilet partitions
 Upgrade room finishes

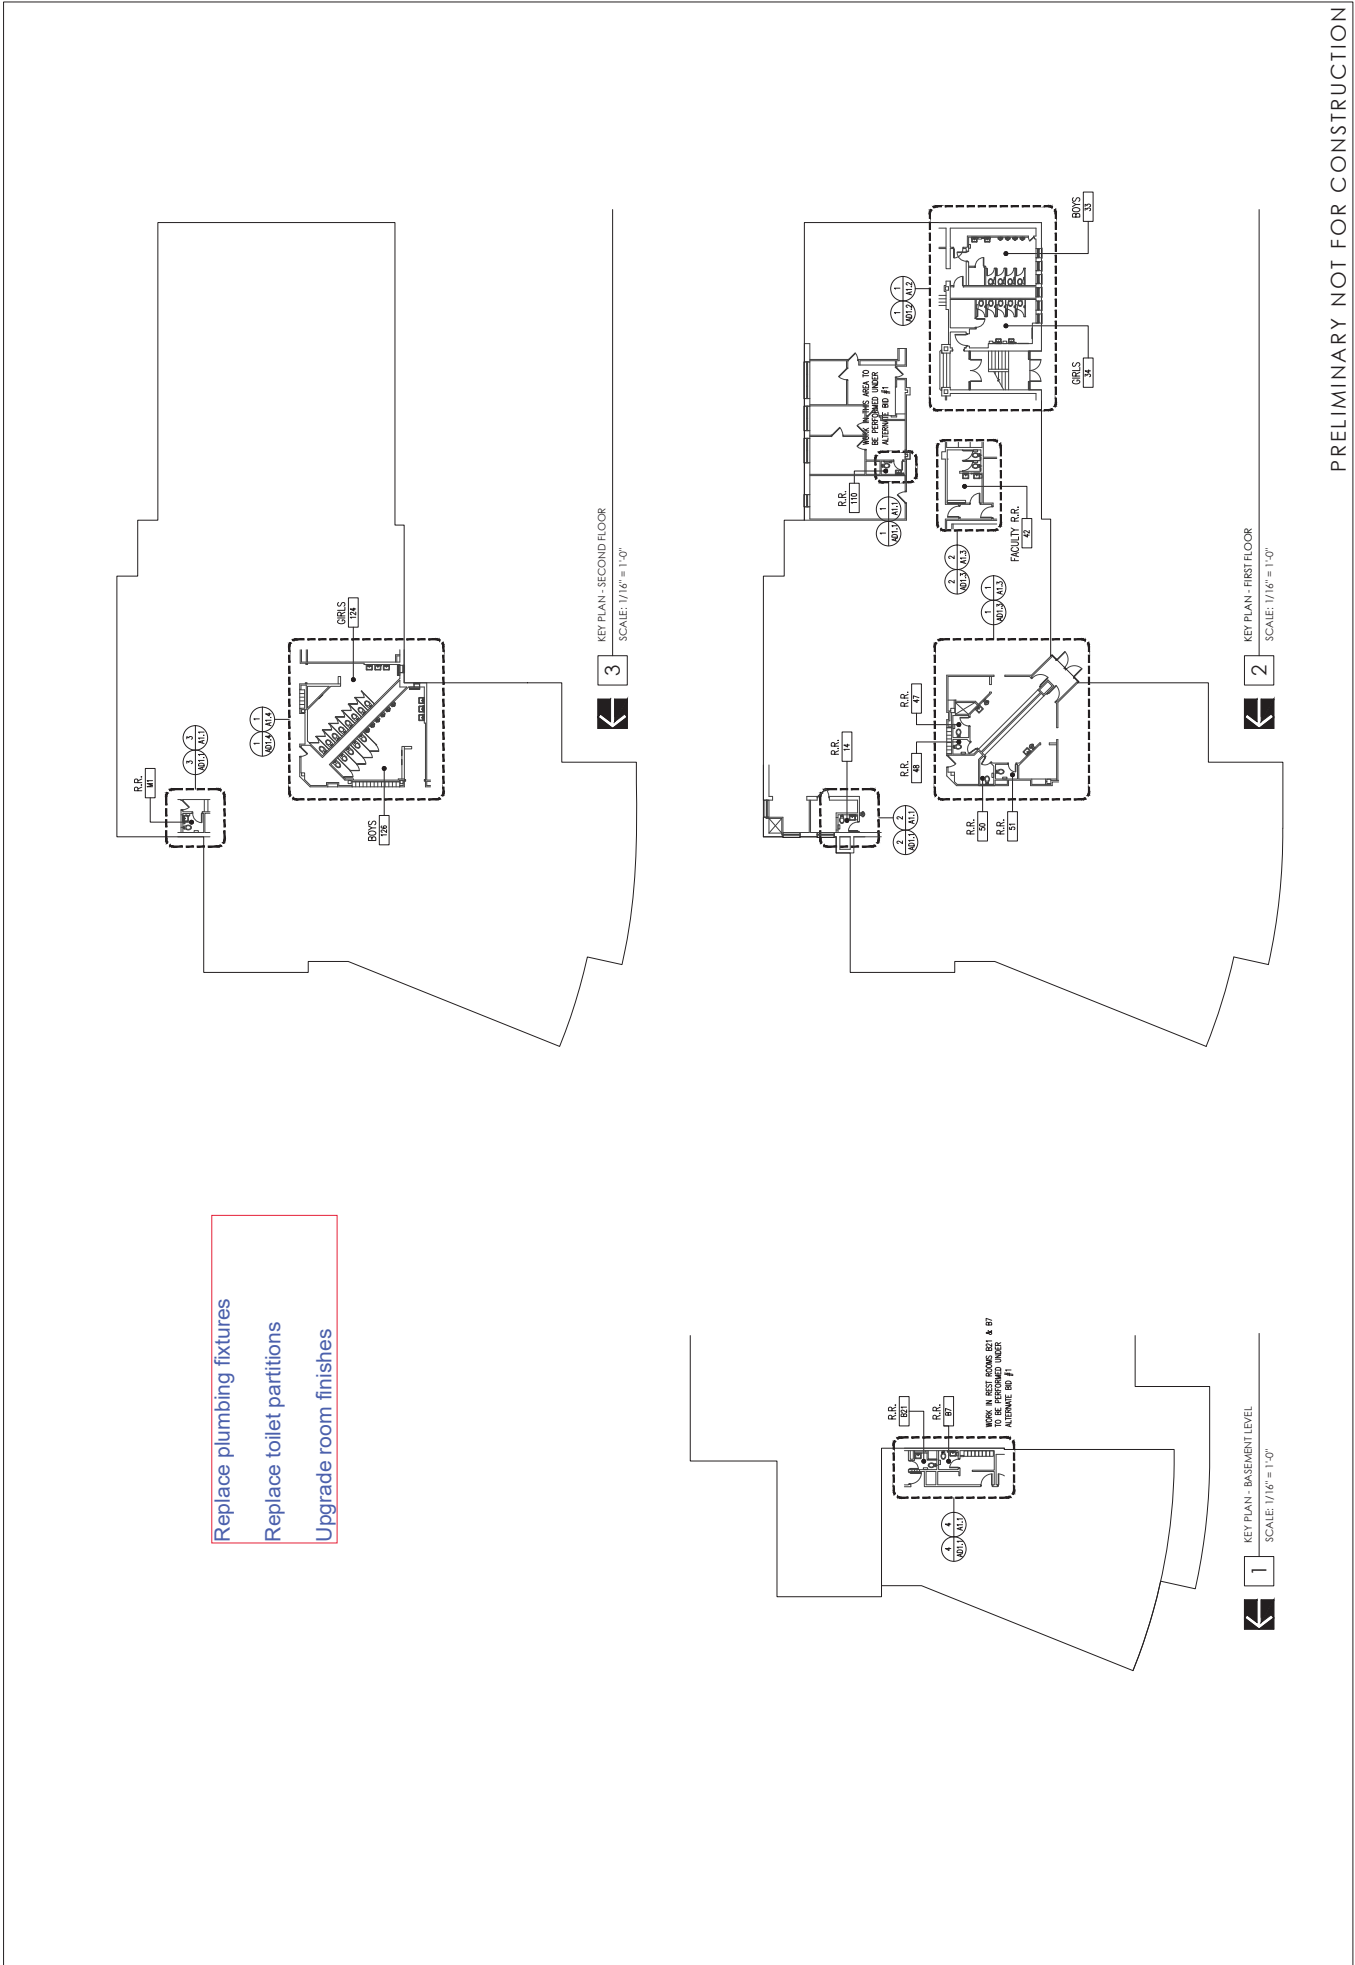

1 KEY PLAN - BASEMENT LEVEL
SCALE: 1/16" = 1'-0"

2 KEY PLAN - FIRST FLOOR
SCALE: 1/16" = 1'-0"

3 KEY PLAN - SECOND FLOOR
SCALE: 1/16" = 1'-0"

WORK IN REST ROOMS 601 & 607
 TOILET PARTITIONS
 ALTERNATE 600 01